



TRON THEATRE Changing House

Plan updated 28/10/2017 by MH

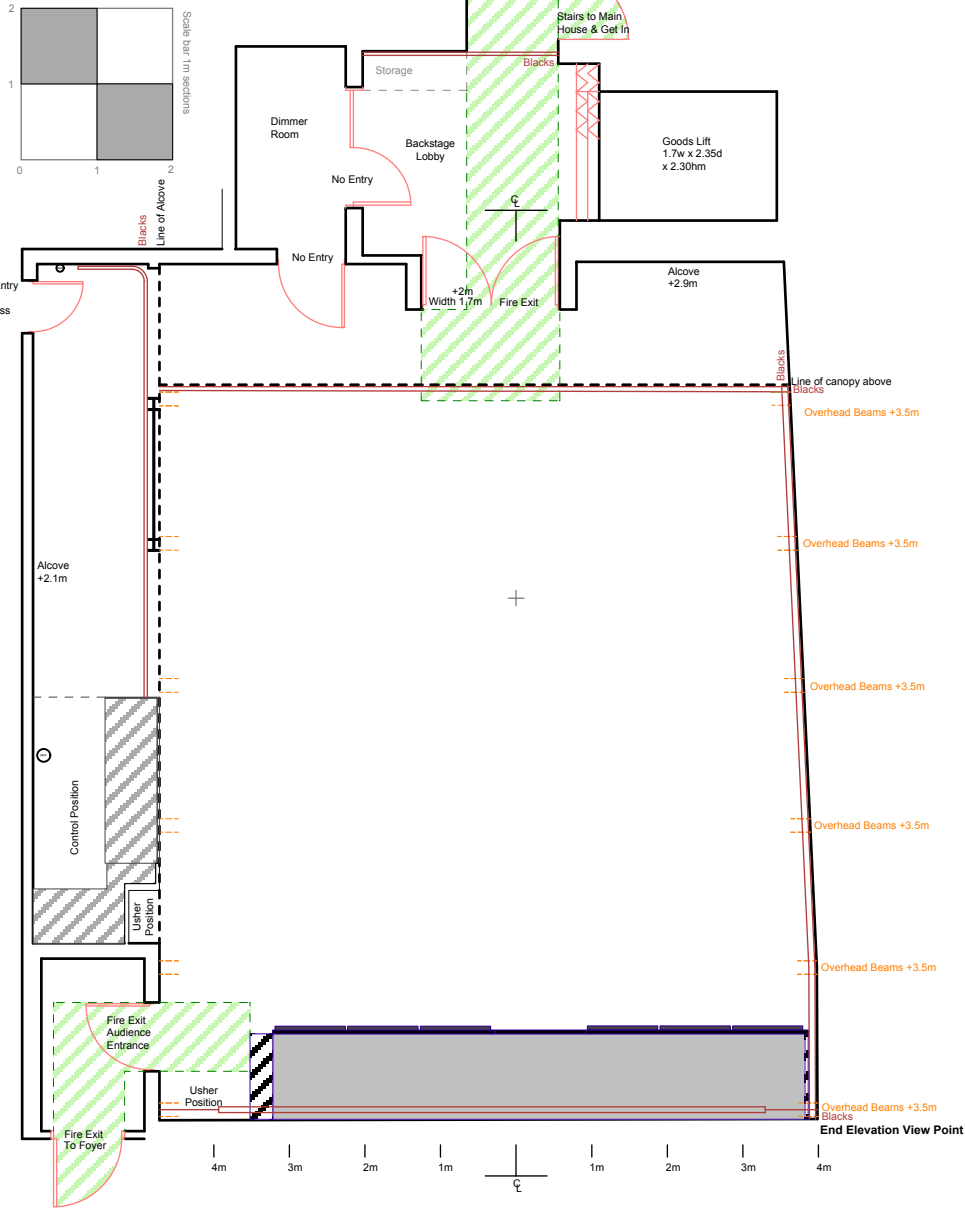

TRON THEATRE Changing House


Plan updated 28/10/2017 by MH

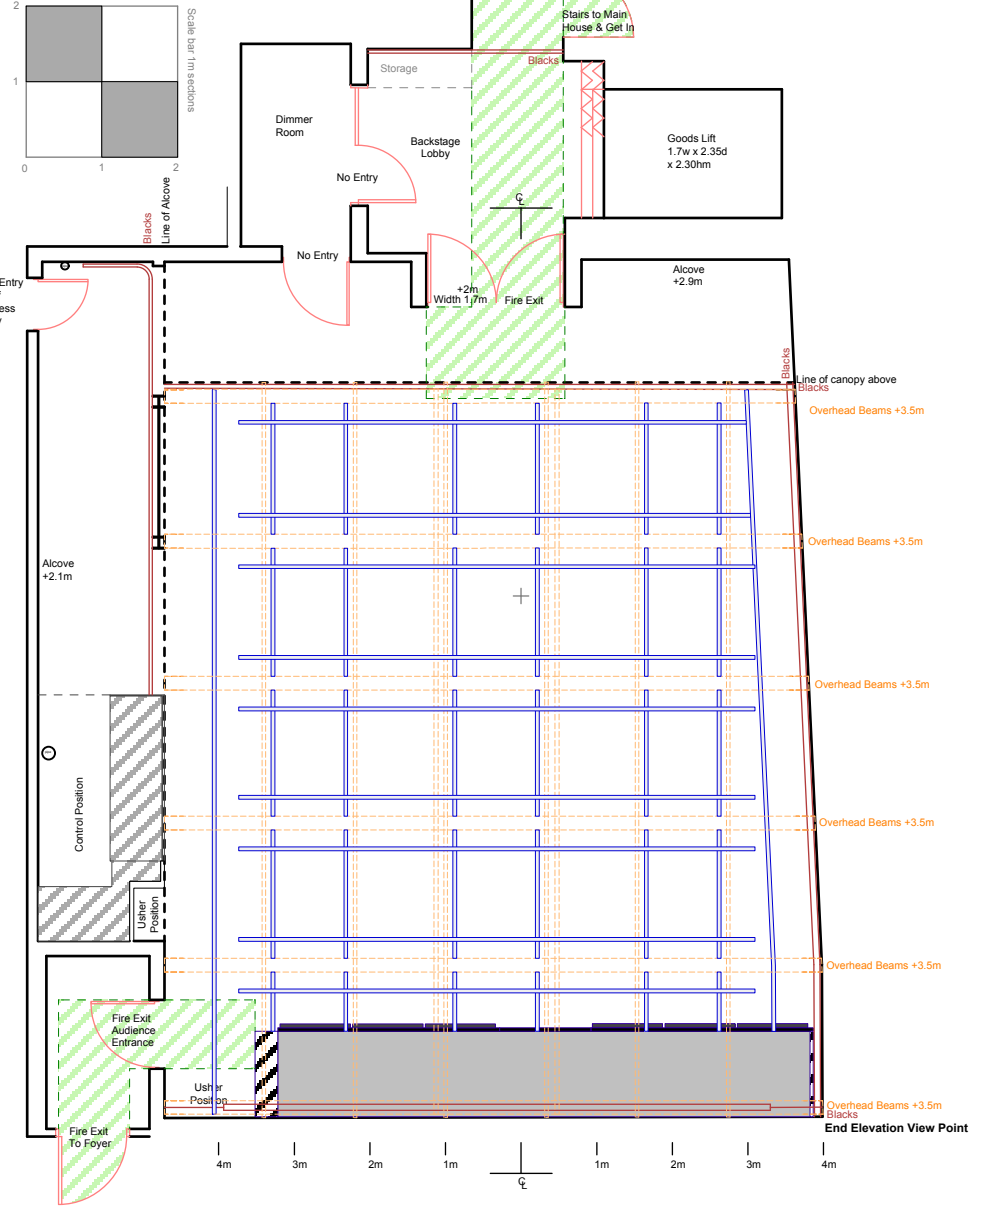

TRON THEATRE Changing House

End Elevation: Towards Stage Wall


Plan updated 18/04/2015 by MH

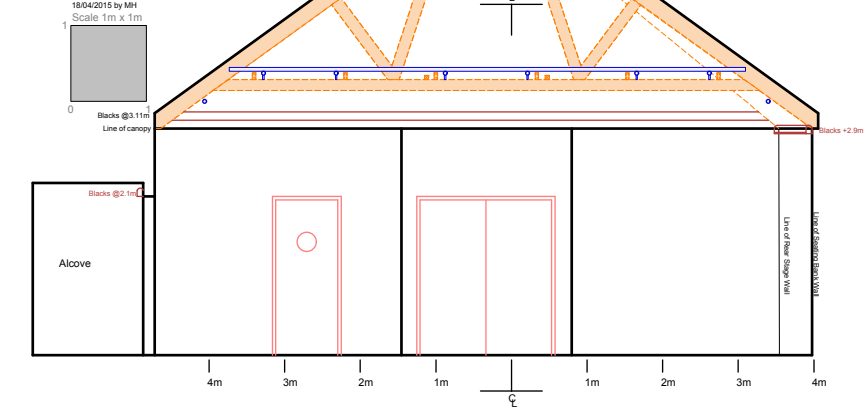

TRON THEATRE Changing House

Side Elevation: From C/L to SL

Plan updated 18/04/2015 by MH

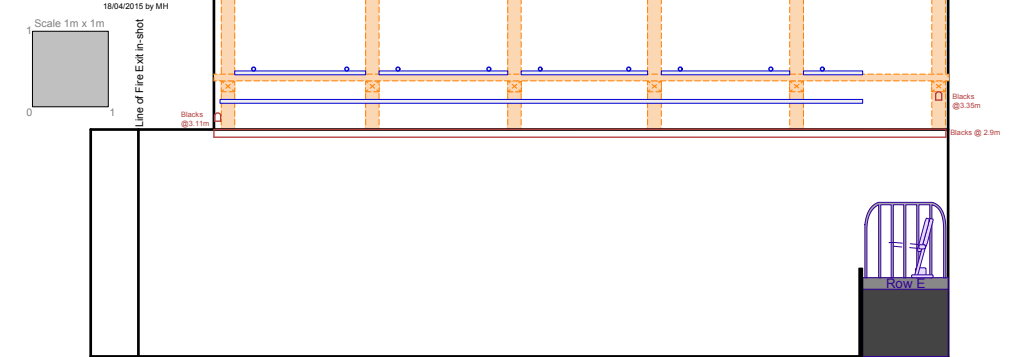


TRON THEATRE Changing House

End Elevation: At Audience Wall

Plan updated 18/04/2015 by MH

Scale 1m x 1m

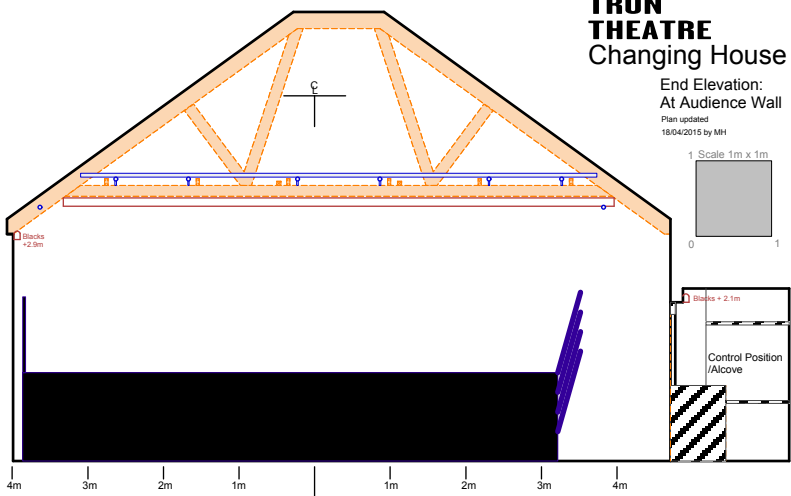


TRON THEATRE Changing House

Side Elevation: From C/L to SR

Plan updated 18/04/2015 by MH

Scale 1m x 1m

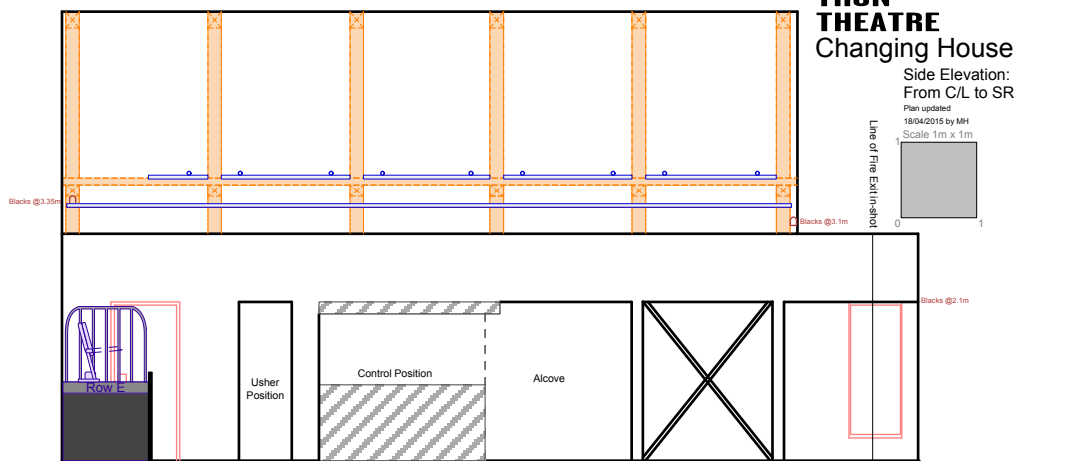

Notes
FIGURED DIMENSION TO BE TAKEN IN PREFERENCE TO SCALED DIMENSIONS
ALL DIMENSIONS TO BE CHECKED ON SITE

Tron Theatre Ltd, 63 Trongate, Glasgow, G1 5HB
Box Office: 0141 552 4267
Bar Kitchen: 0141 552 8587

Tron Theatre Ltd is a Scottish registered charity, No: SC012081
Glasgow City Council
Creative Scotland

Scale 1:100 @ A3

Show Name Tron - Changing House		
Reference Lighting Plan	Drawn By M Hughes	Date 28/08/2014
CAD File Name Changing House, Tron Theatre		