
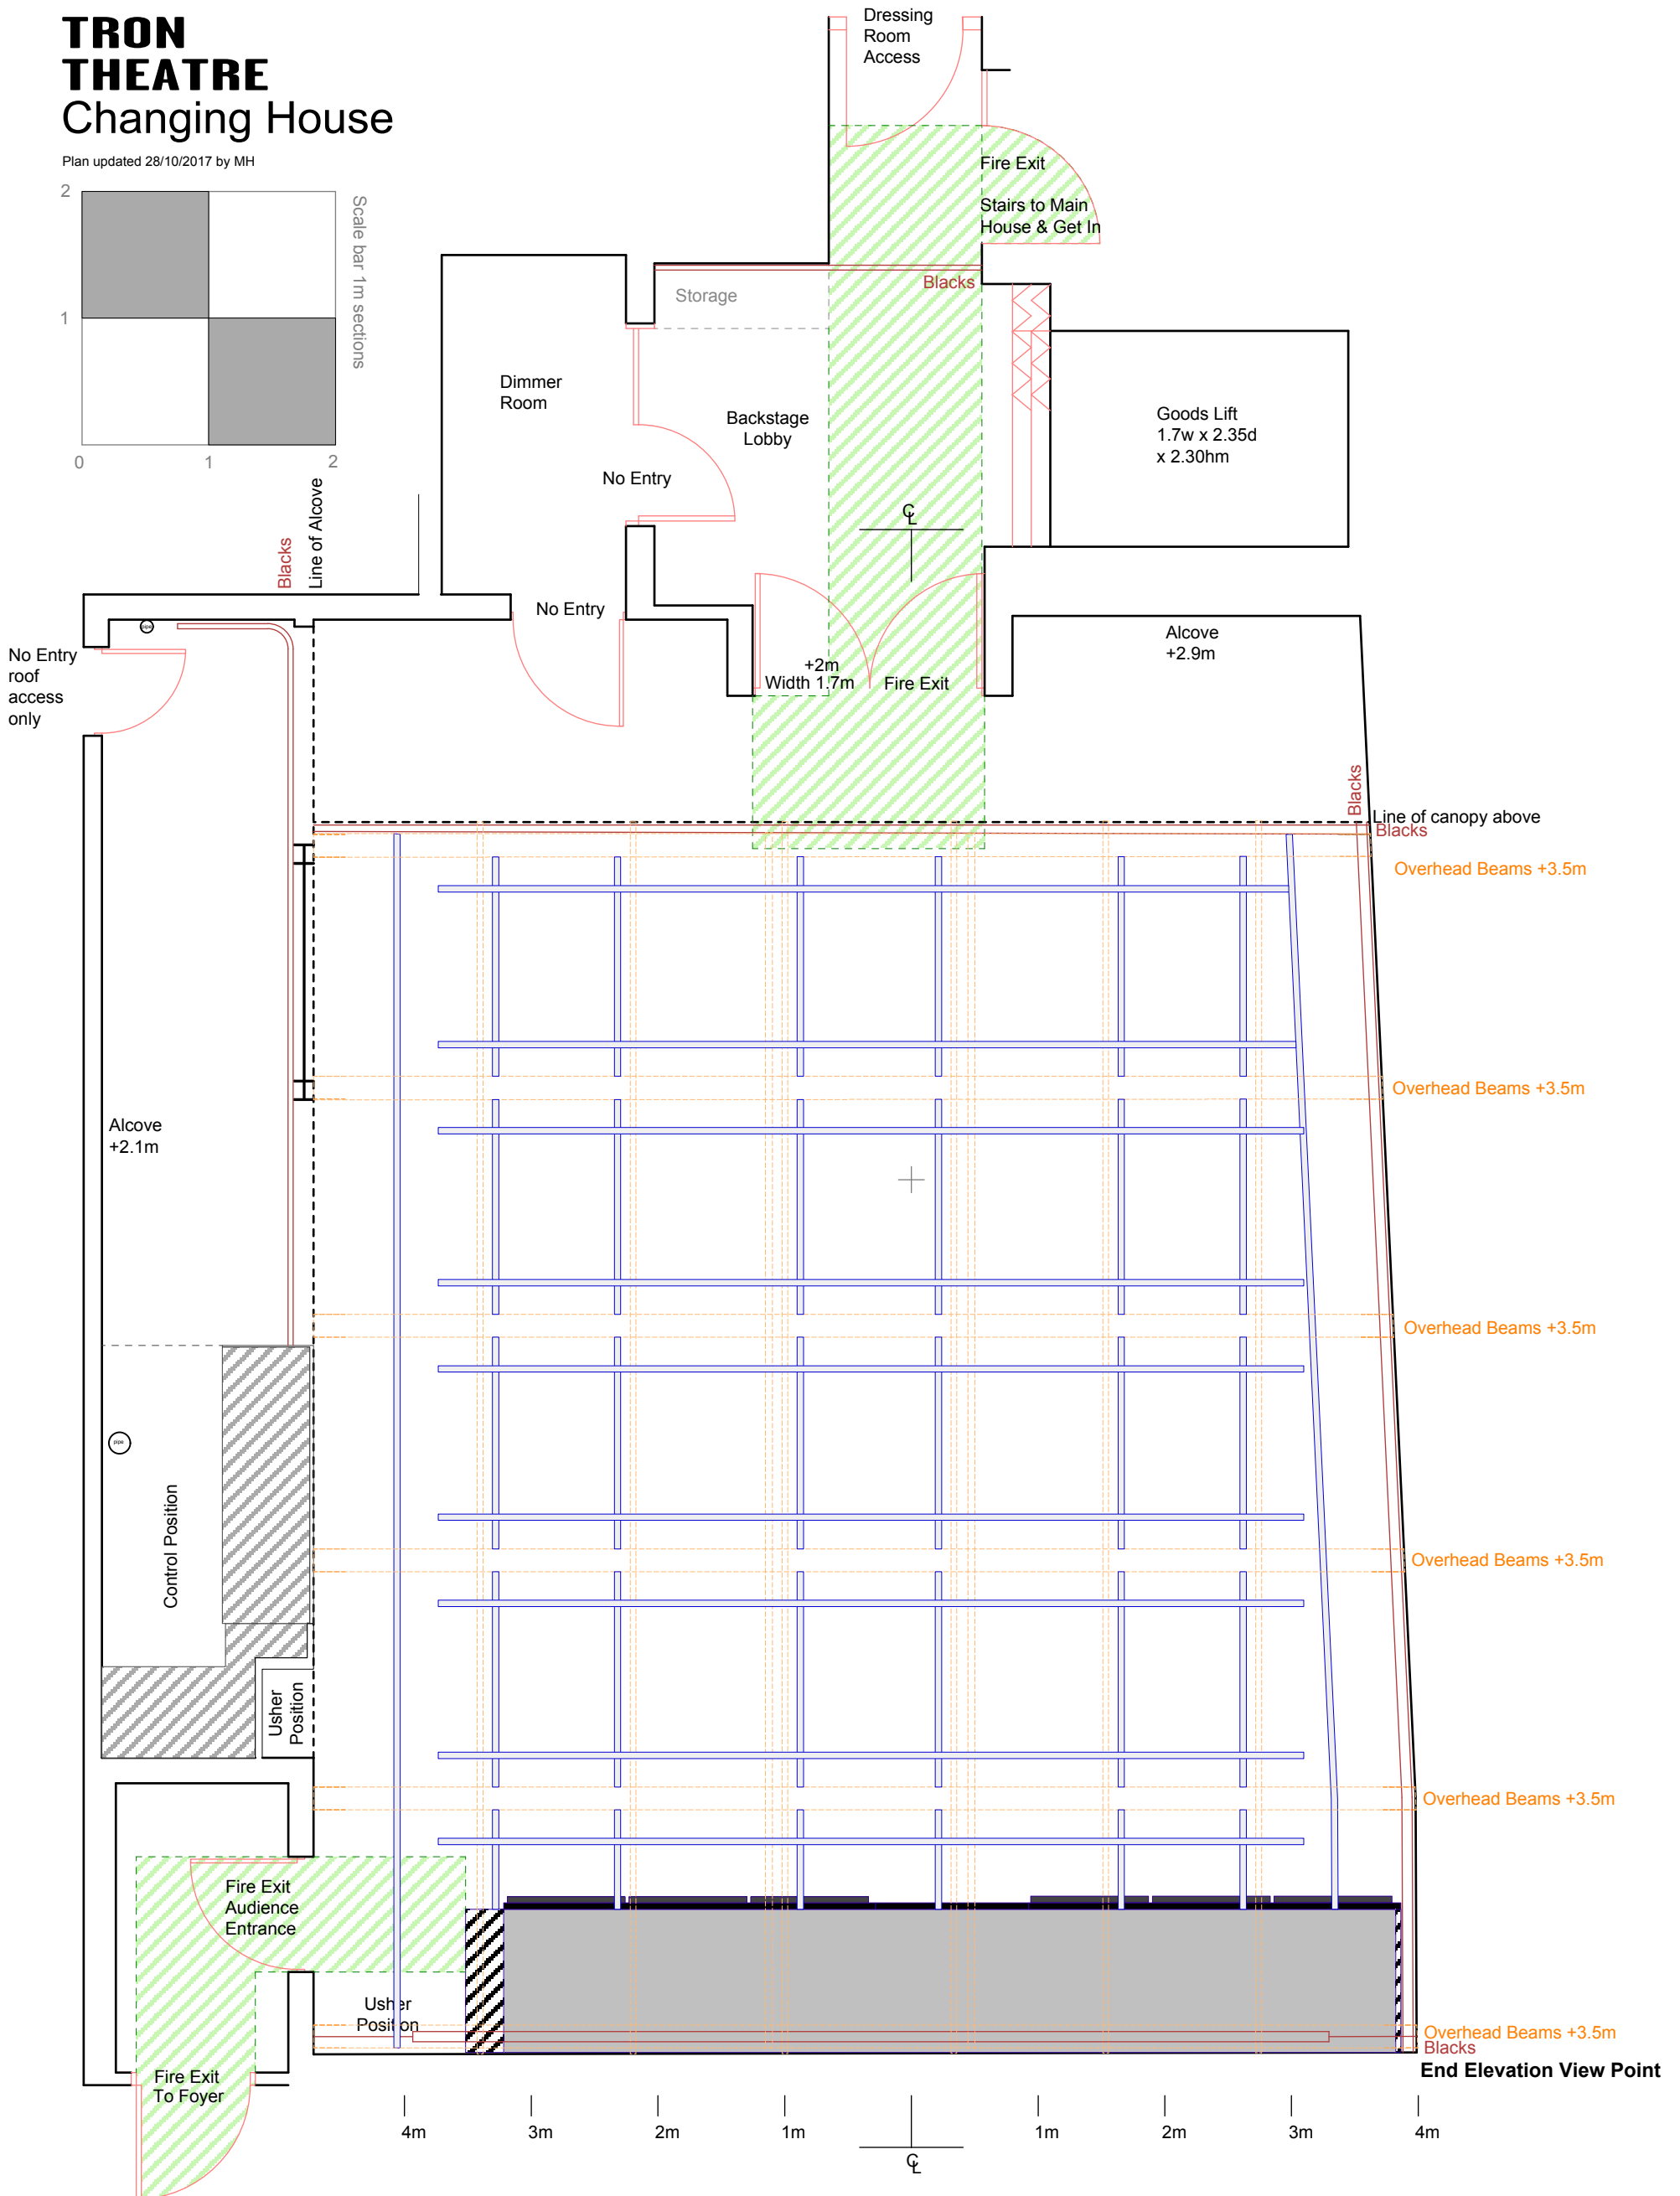


# TRON THEATRE

## Changing House

Plan updated 28/10/2017 by MH

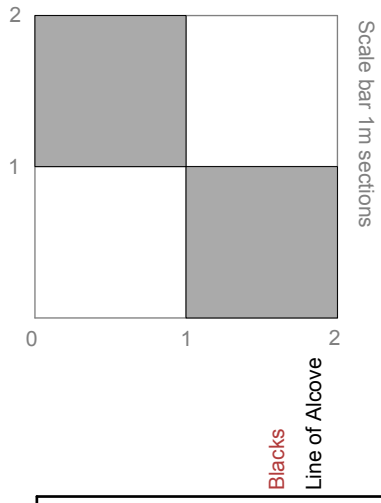

Notes  
 FIGURED DIMENSION TO BE TAKEN IN PREFERENCE TO SCALED DIMENSIONS  
 ALL DIMENSIONS TO BE CHECKED ON SITE

Tron Theatre Ltd, 63 Trongate, Glasgow, G1 5HB  
 Box Office: 0141 552 4267  
 Bar Kitchen: 0141 552 8587

Tron Theatre Ltd is a Scottish registered charity, No: SC012081  
 Glasgow City Council  
 Creative Scotland

Scale 1:50 @ A3

Show Name Tron - Changing House		
Reference Lighting Plan	Drawn By M Hughes	Date 28/08/2014
CAD File Name Changing House, Tron Theatre		